




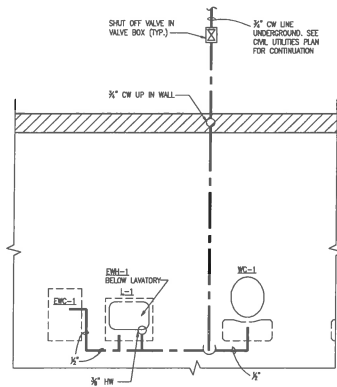


2
TYPICAL RESTROOM
WATER PLAN
P201 SCALE: 1/2" = 1' - 0"

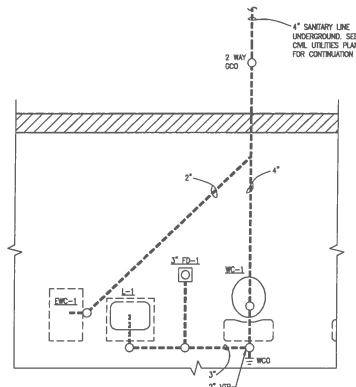


3
TYPICAL RESTROOM
SANITARY PLAN
P201 SCALE: 1/2" = 1' - 0"

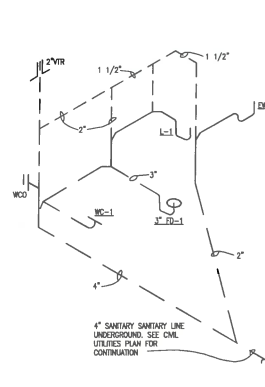

4
TYPICAL SANITARY
RISER DIAGRAM
P201 SCALE: NOT TO SCALE

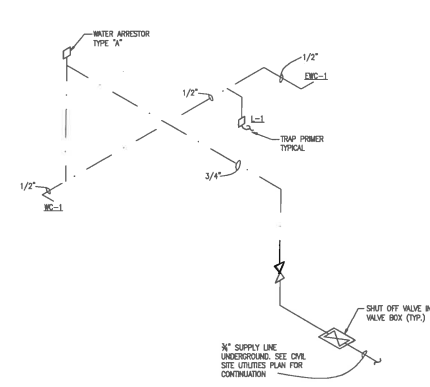

5
TYPICAL WATER
RISER DIAGRAM
P201 SCALE: NOT TO SCALE

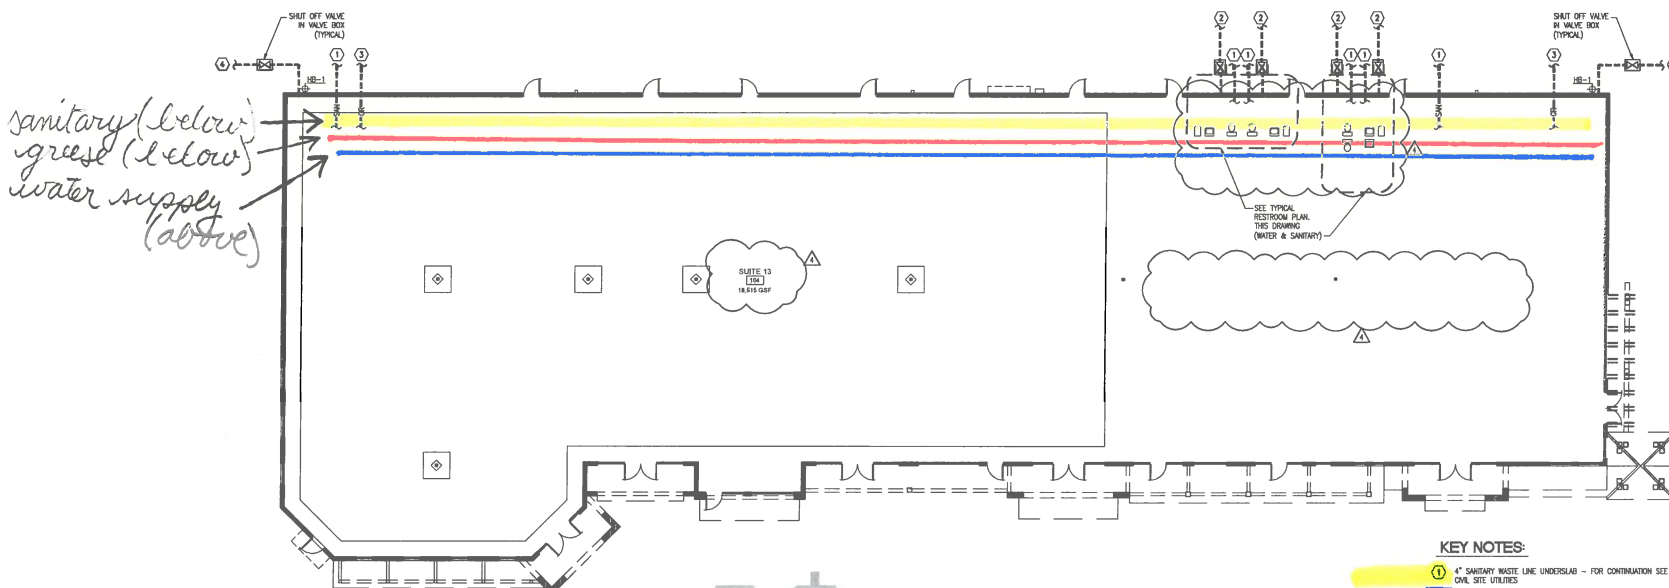

ALL DETAILS FOR REFERENCE ONLY
SCOPE OF WORK SHALL BE PLUMBING
STUB-UPS AT INTERIOR SIDE.



KEY NOTES:

- ① 4" SANITARY WASTE LINE UNDERSLAB - FOR CONTINUATION SEE CIVIL SITE UTILITIES
- ② 4" DOMESTIC WATER SUPPLY LINE UNDERGROUND - FOR CONTINUATION SEE CIVIL SITE UTILITIES PLAN
- ③ 4" GREASE WASTE RUN UNDERGROUND TO NEW GREASE INTERCEPTIONS. SEE CIVIL SITE UTILITIES PLAN FOR CONTINUATION. RUN GREASE LINES SEPARATELY TO OUTSIDE OF BUILDING
- ④ 3/4" DOMESTIC WATER SUPPLY LINE UNDERGROUND - FOR CONTINUATION SEE CIVIL SITE UTILITIES PLAN



Owner:

ALI JAWAD

PLUMBING PLAN

PLANTATION PLAZA
HWY 27
LEESBURG, FLORIDA

Architect of Record
John W. Bur - AP0000

Revision
10-01-01-0000 REVIEW CHANGES

Date
06-05-2019
Drawn by
RR
Checked by
JWB

Project No.
13-019

Sheet No.

P201